


STRUCTURE DETAIL

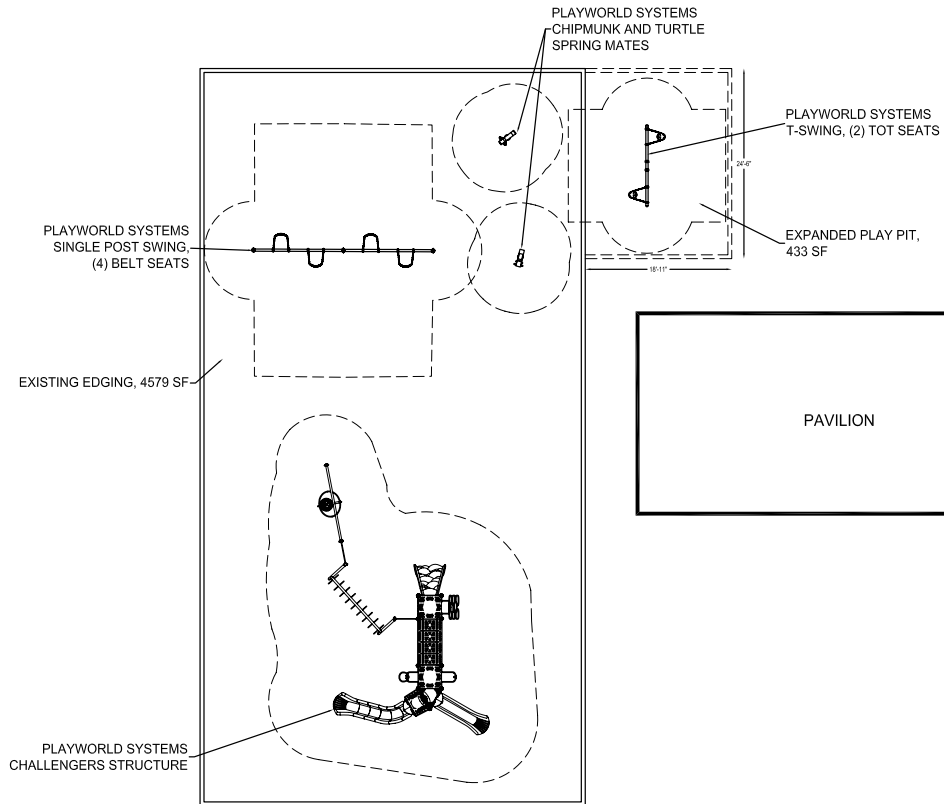

2008 CHALLENGERS

COMPLIES WITH:

- ASTM F1487-01
- ASTM F1487-98
- CPSC #325
- ADA - ADAAG
- CSA Z614-03

SITE PLAN

PROJECT NO: P41008-2B	REV: B
DATE: 4/10/08	
SCALE: 1/16" = 1'-0"	
DRAWN BY: TKA	

playground Specialists Inc.

Recreation Design & Installation, Site Amenities, and Safety Surfacing

PLAYWORLD™

© 2007 Playworld Systems, Inc.
Playworld™ is a brand of Playworld Systems, Inc.

Plantations HOA

Montgomery County, MD

PLAYGROUND SPECIALISTS

17352 N. Seton Ave.
Emmitsburg, MD
800-385-0075