

PLUMBING LEGEND


CW	COLD WATER		BALL VALVE
HW	HOT WATER		DIRECTION OF FLOW
- - -	EXISTING PIPING AS DESIGNATED ON DWGS.		

PLUMBING GENERAL NOTES


1. REFER TO ISOMETRIC RISER DIAGRAM, SHEET P5, FOR PIPE SIZES.
2. ALL WATER CLOSETS SHALL BE CAULKED TO FLOOR. ALL FIXTURES SHALL BE CAULKED TO ADJACENT SURFACE.

PLUMBING KEYED NOTES:

1. EXISTING INCOMING DOMESTIC WATER SERVICE, INCLUDING RPZ BACKFLOW PREVENTER AND ISOLATION VALVE.
2. NEW WATER HEATER W/EXPANSION TANK, TAP VALVE, RECIRCULATION PUMP, CHECK VALVES, ETC. REFER TO P4/3 FOR DETAIL.
3. 1/2" HW/CW DOWN TO LAVATORY BELOW. PROVIDE WITH 3/8" STOP.
4. 1/2" CW DOWN TO WATER CLOSET BELOW. PROVIDE WITH 3/8" STOP.
5. 1/2" HW/CW DOWN TO NEW SINK BELOW. PROVIDE WITH 3/8" STOP.
6. 1/2" CW DOWN TO TRAP PRIMER. PROVIDE ACCESS PANEL IN ACCESSIBLE WALL LOCATION (NOT BEHIND WATER HEATER).
7. CONTRACTOR TO PROVIDE AND INSTALL A FROST-PROOF HOSE BIBB, 24" AFF. WITH KEYED LOCK. DELIVER KEY TO OWNER AT COMPLETION OF CONSTRUCTION. PROVIDE ACCESSIBLE ISOLATION VALVE ABOVE RESTROOM CEILING.
8. EXISTING EXTERIOR FROST-PROOF HOSE BIBB.

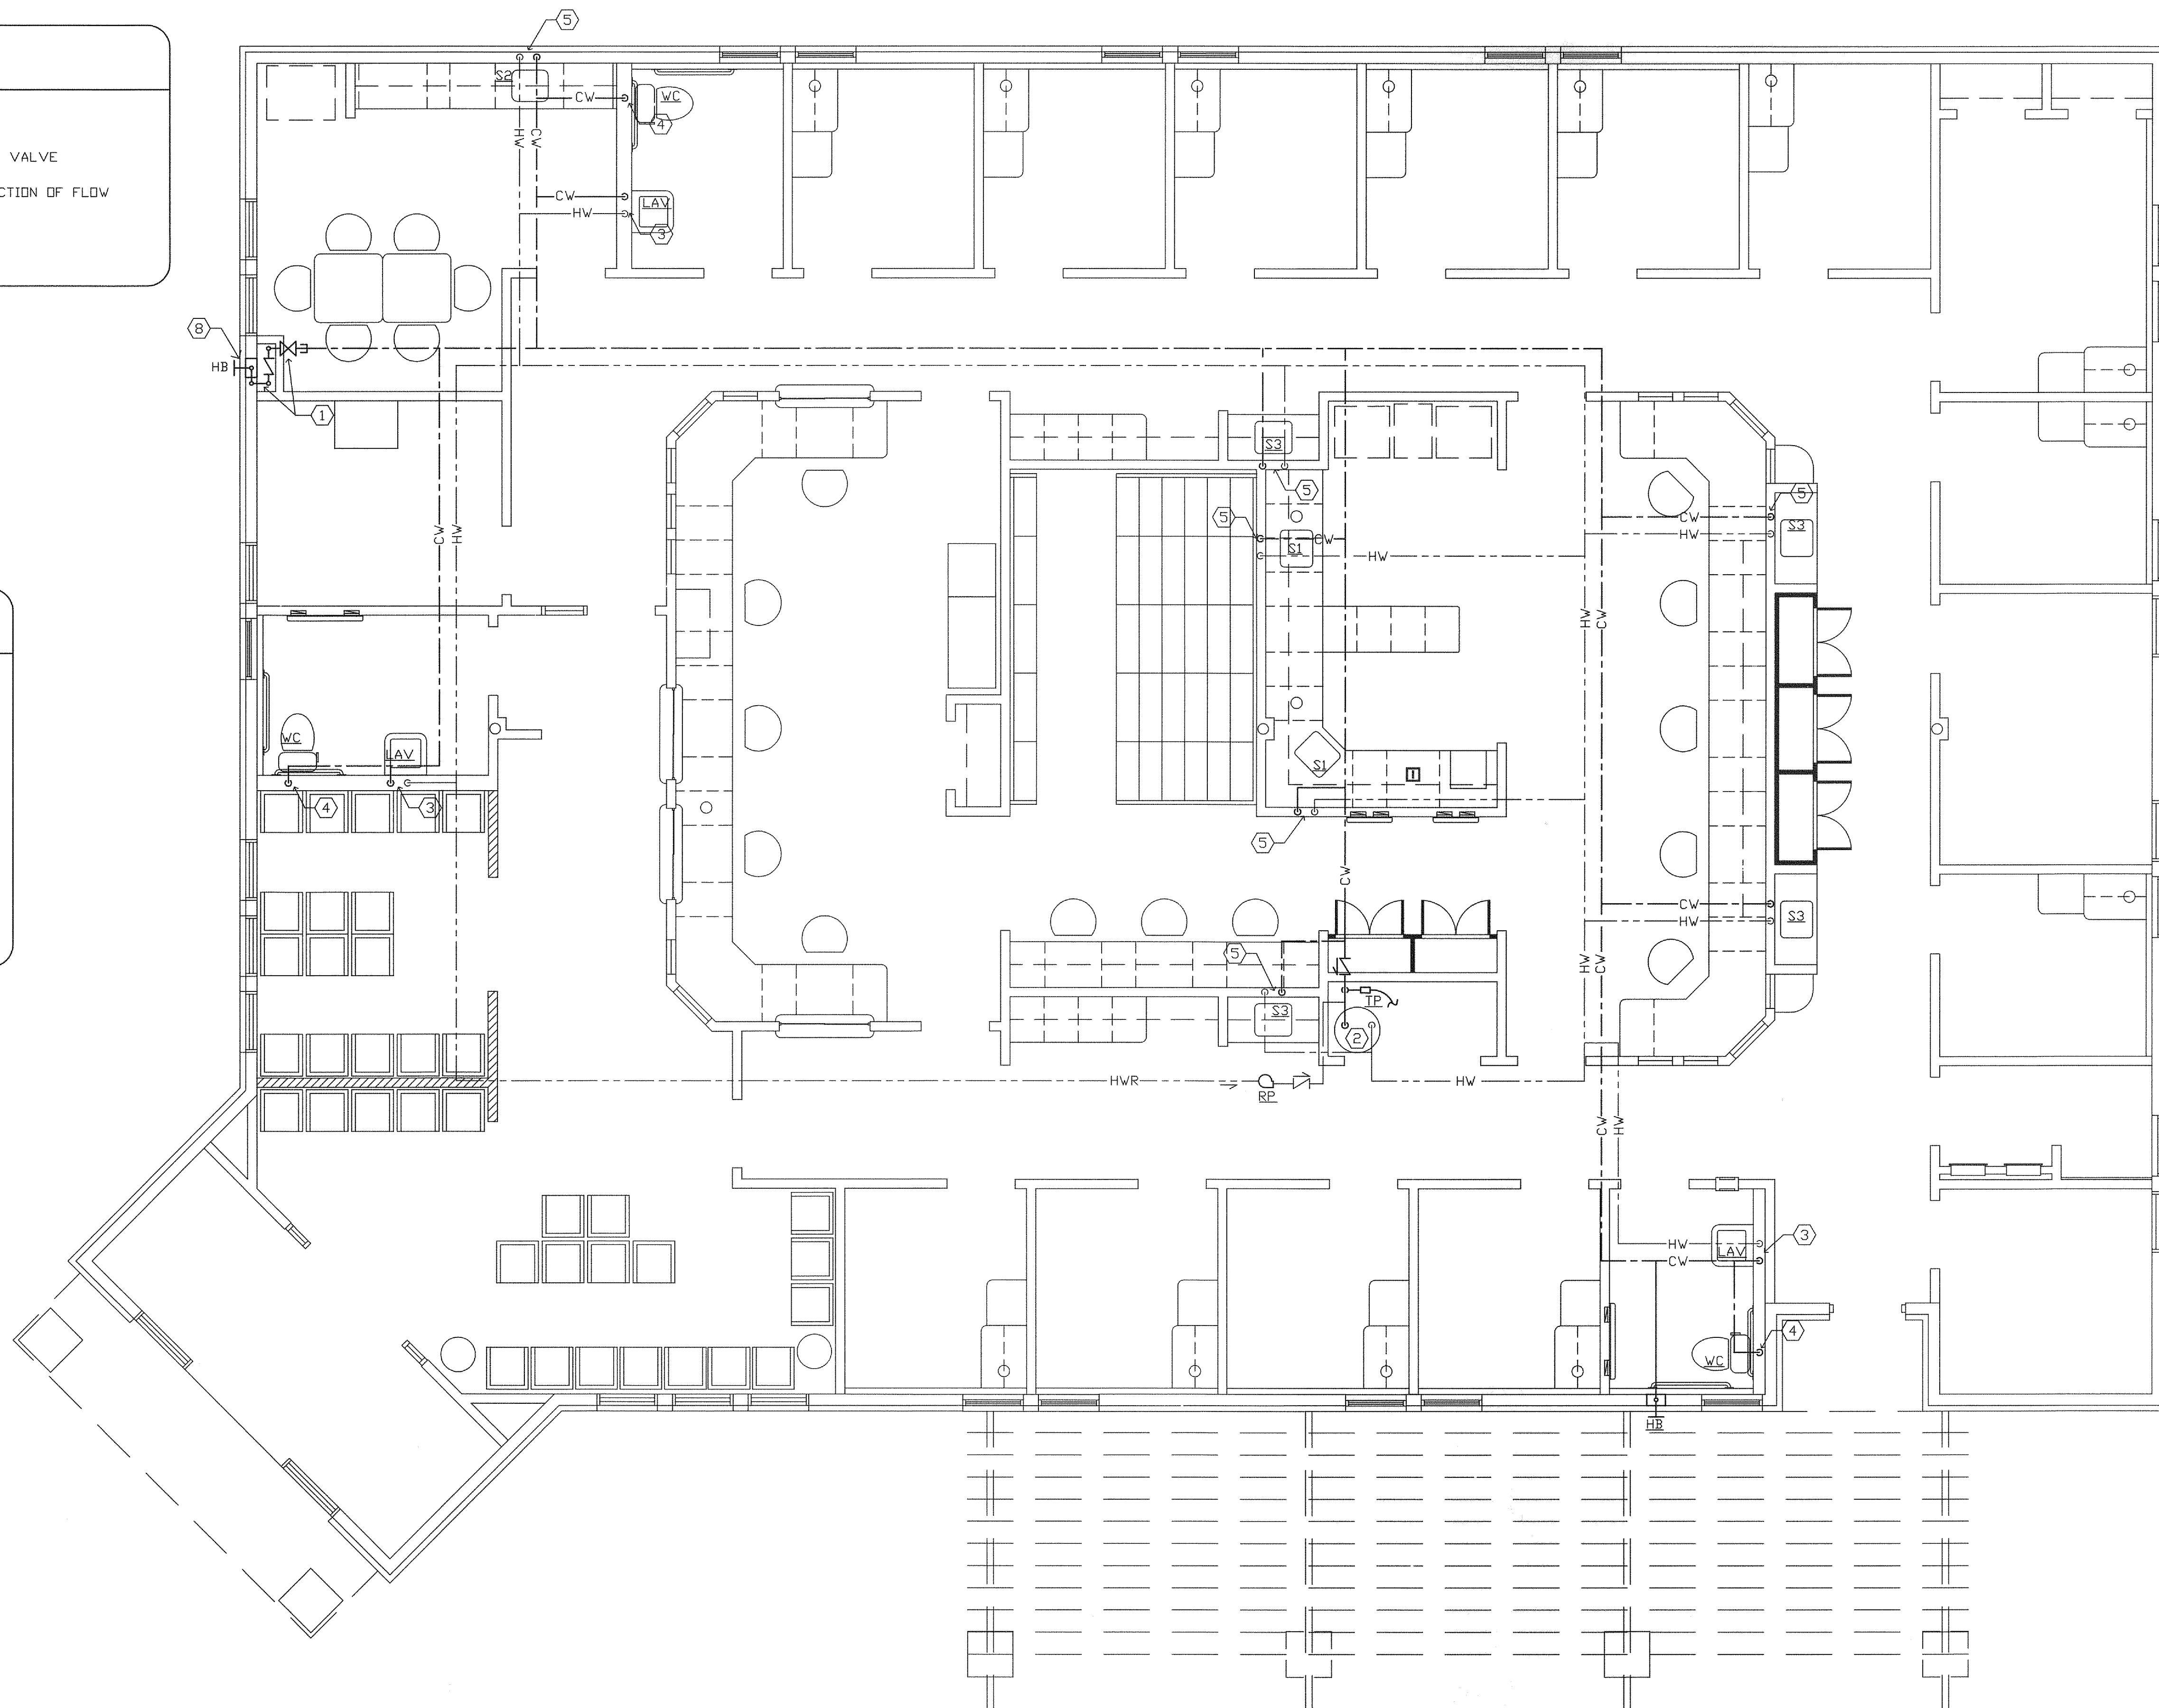

PLAN NORTH

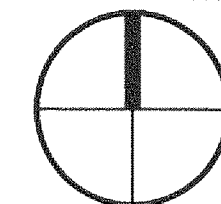


1 WATER PIPING PLAN

SCALE: 1/4" = 1'-0"

01-24-08 OWNER REVISIONS

NO. | DATE | REVISIONS

CONTRACTOR SHALL VERIFY ALL DIMENSIONS AT THE JOB SITE AND NOTIFY THE ARCHITECTS OF ANY DIMENSIONAL ERRORS, OMISSIONS OR DISCREPANCIES BEFORE BEGINNING OR FABRICATING ANY WORK
DO NOT SCALE DRAWINGS

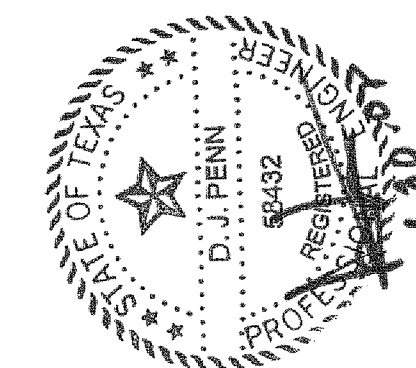

linear!

the architecture of Kemery Brundige and Young

5005 W. Royal Lane Suite 144
Ft. Worth, TX 76107
Phone: 972.929.9226
Fax: 972.929.9061
inbox@linear-architecture.com

COOK CHILDREN'S
PRIMARY CARE CLINIC

FT. WORTH, TX

JOB NUMBER
07.210

SHEET TITLE
**WATER AND
GAS PIPING
PLAN**

SHEET NUMBER

P2

DATE OF ORIGINAL ISSUE
© 29 NOVEMBER 2007