



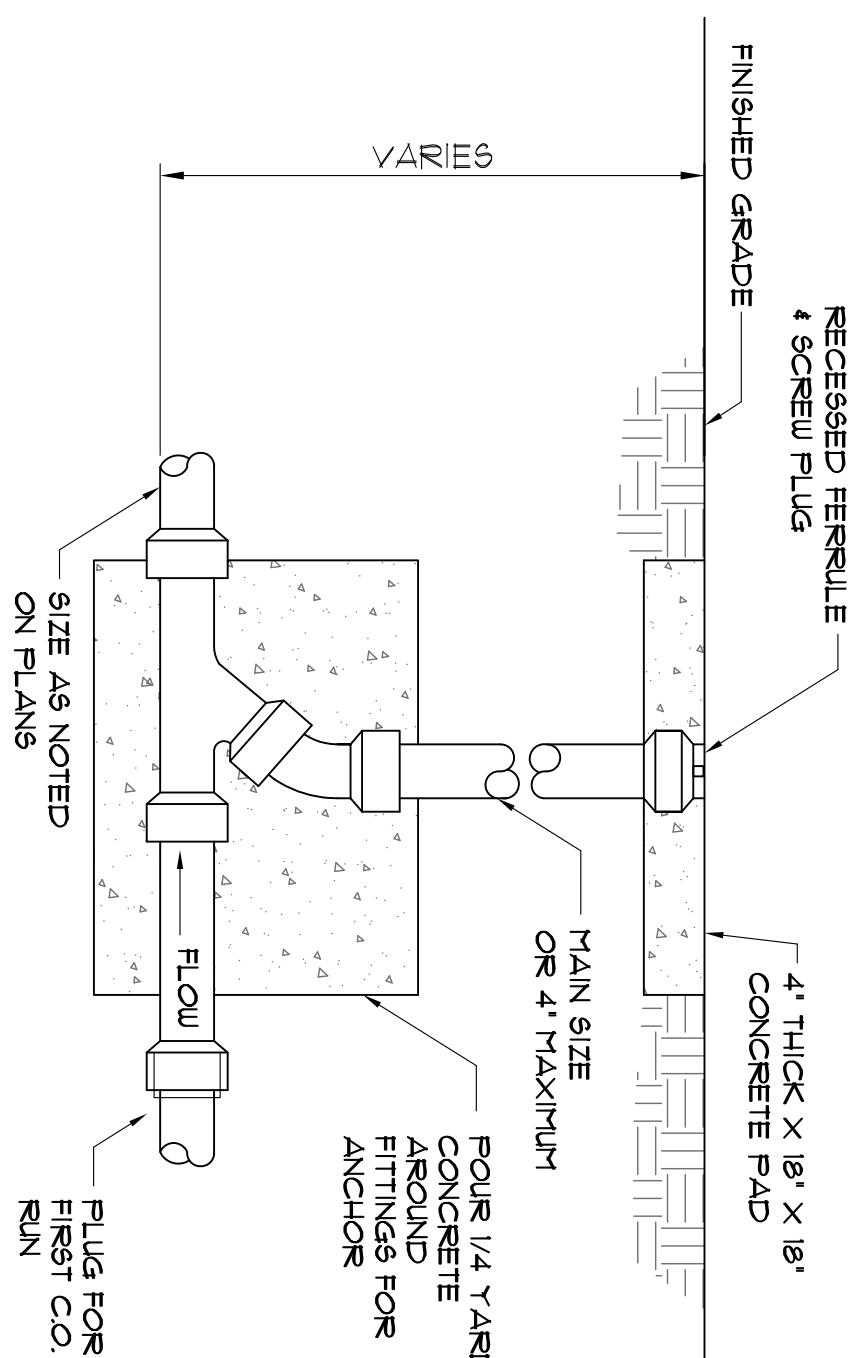


Ø2 GRADE CLEANOUT DETAIL

NO SCALE

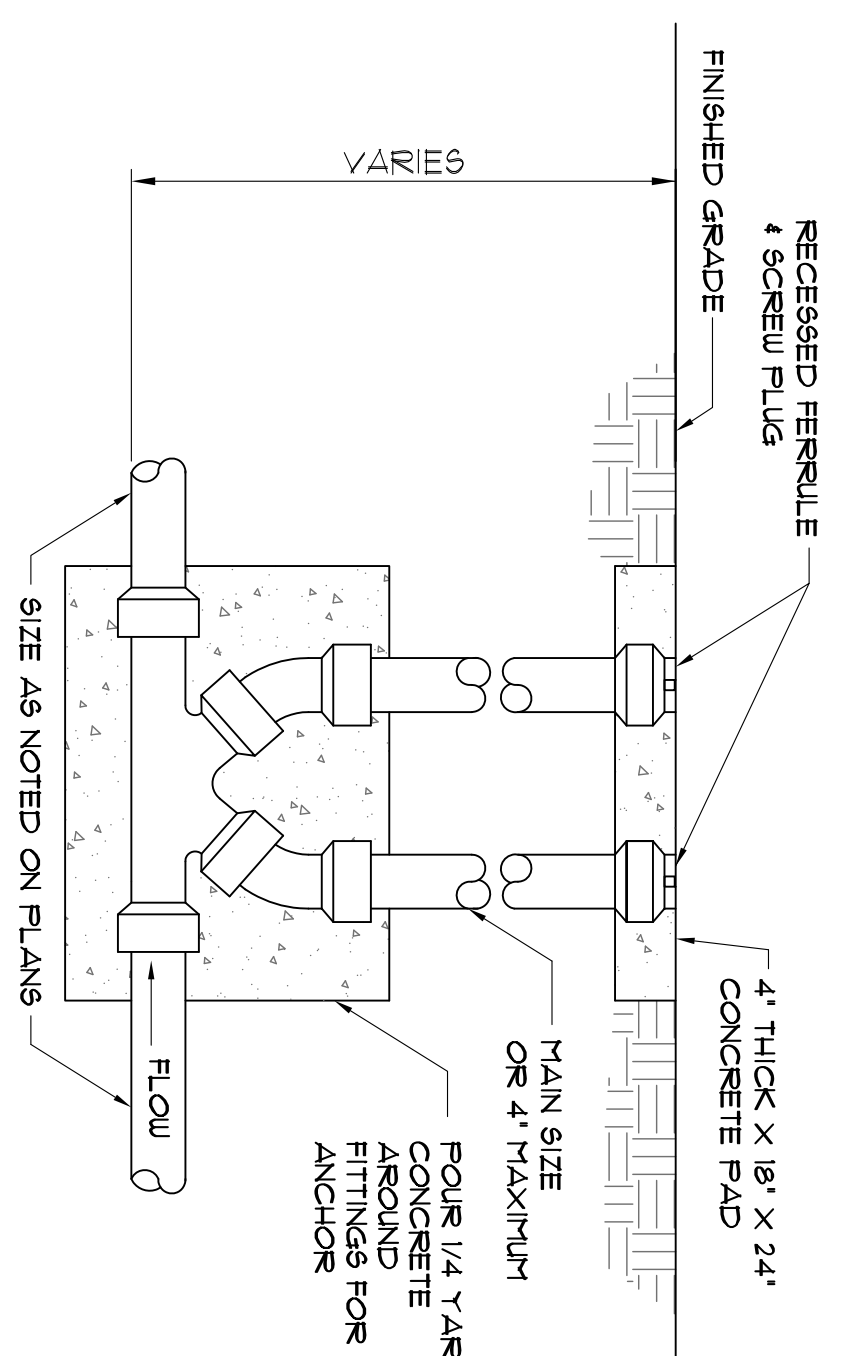


Ø3 TWO-WAY GRADE CLEANOUT DETAIL

NO SCALE

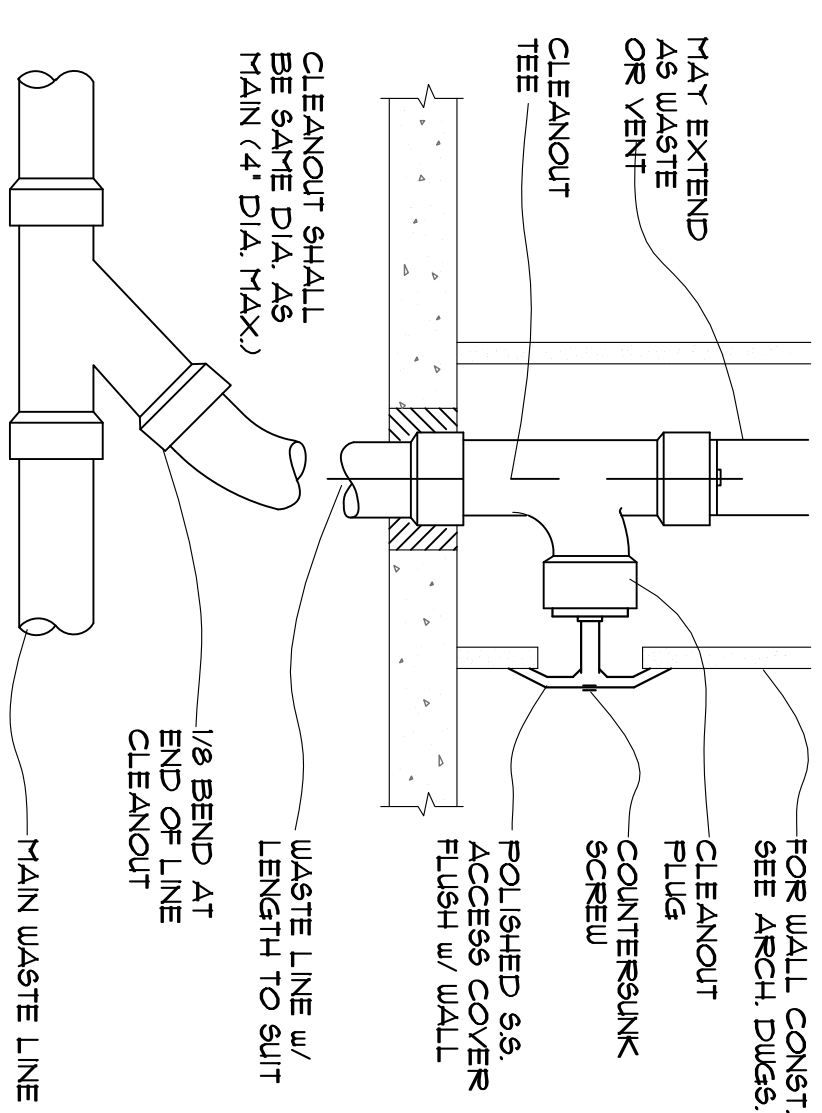


Ø4 WALL CLEANOUT DETAIL

NO SCALE

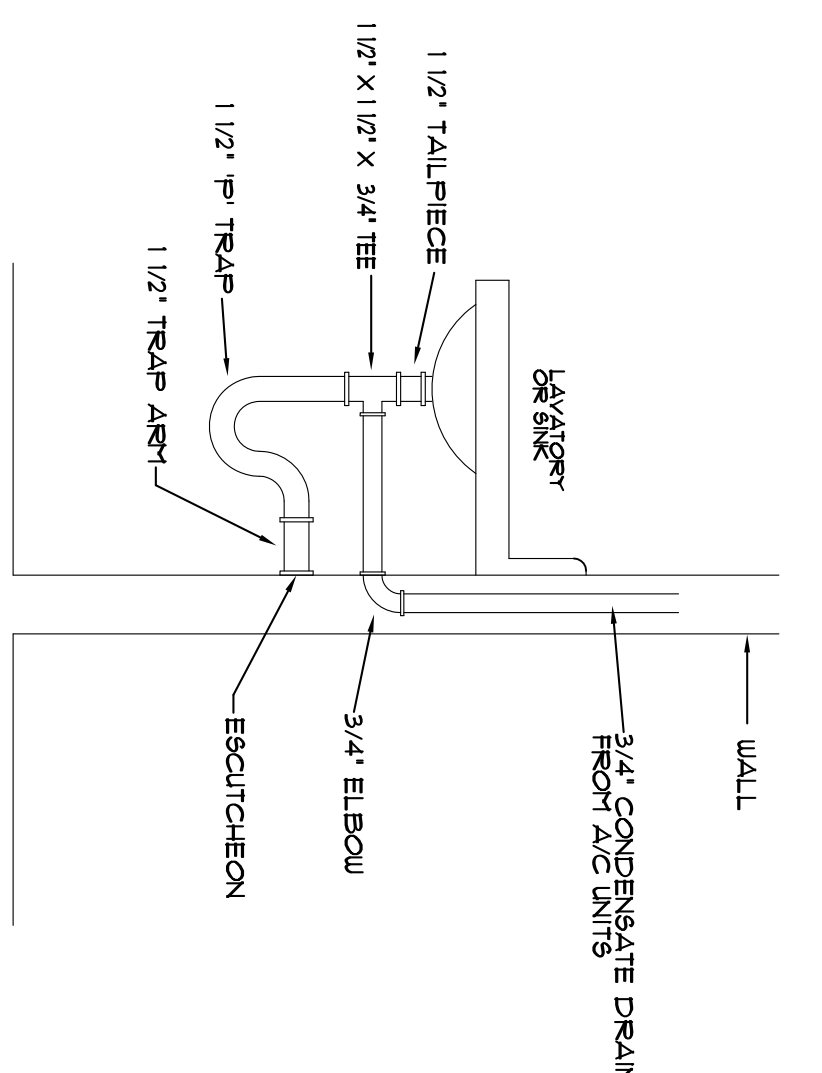

Ø5 CONDENSATE DETAIL
NO SCALE

NO SCALE

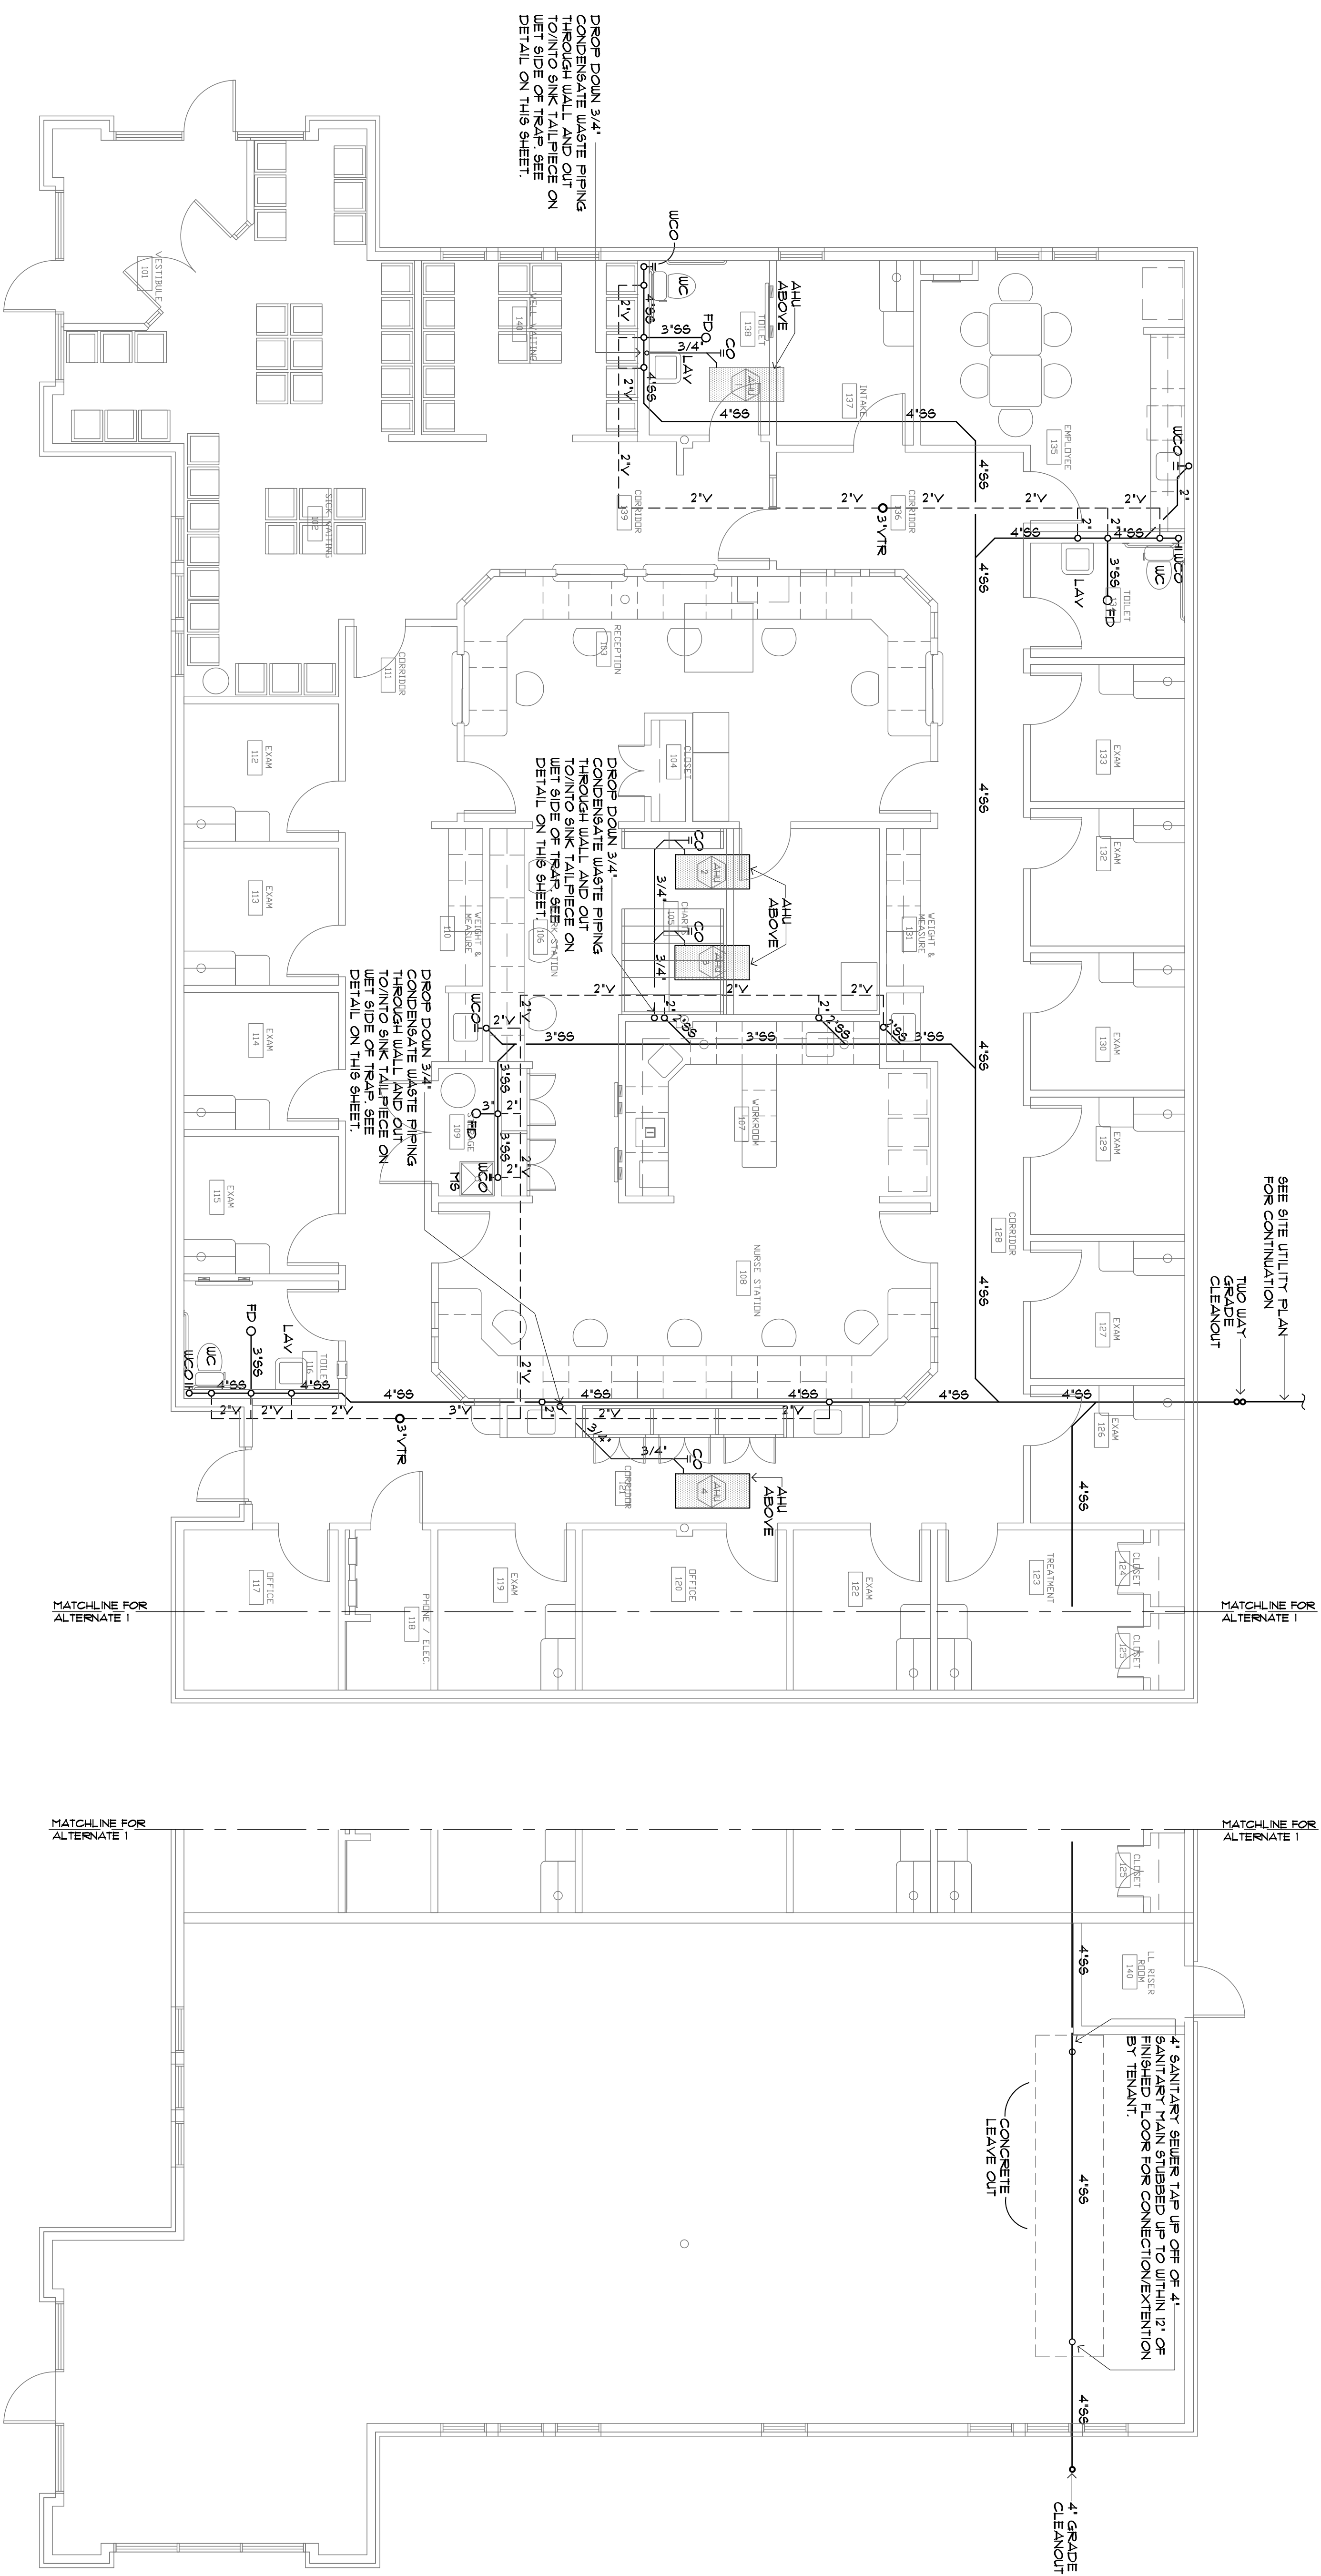

Ø1 COOKS WASTE AND VENT PIPING PLAN

 $3/16" = 1'-0"$

Ø2 ALTERNATE 1 WASTE AND VENT PIPING PLAN

 $3/16' = 1'-0''$

FOR BIDDING PURPOSES ONLY